


# CHERUVU MADHARAM BRANCH

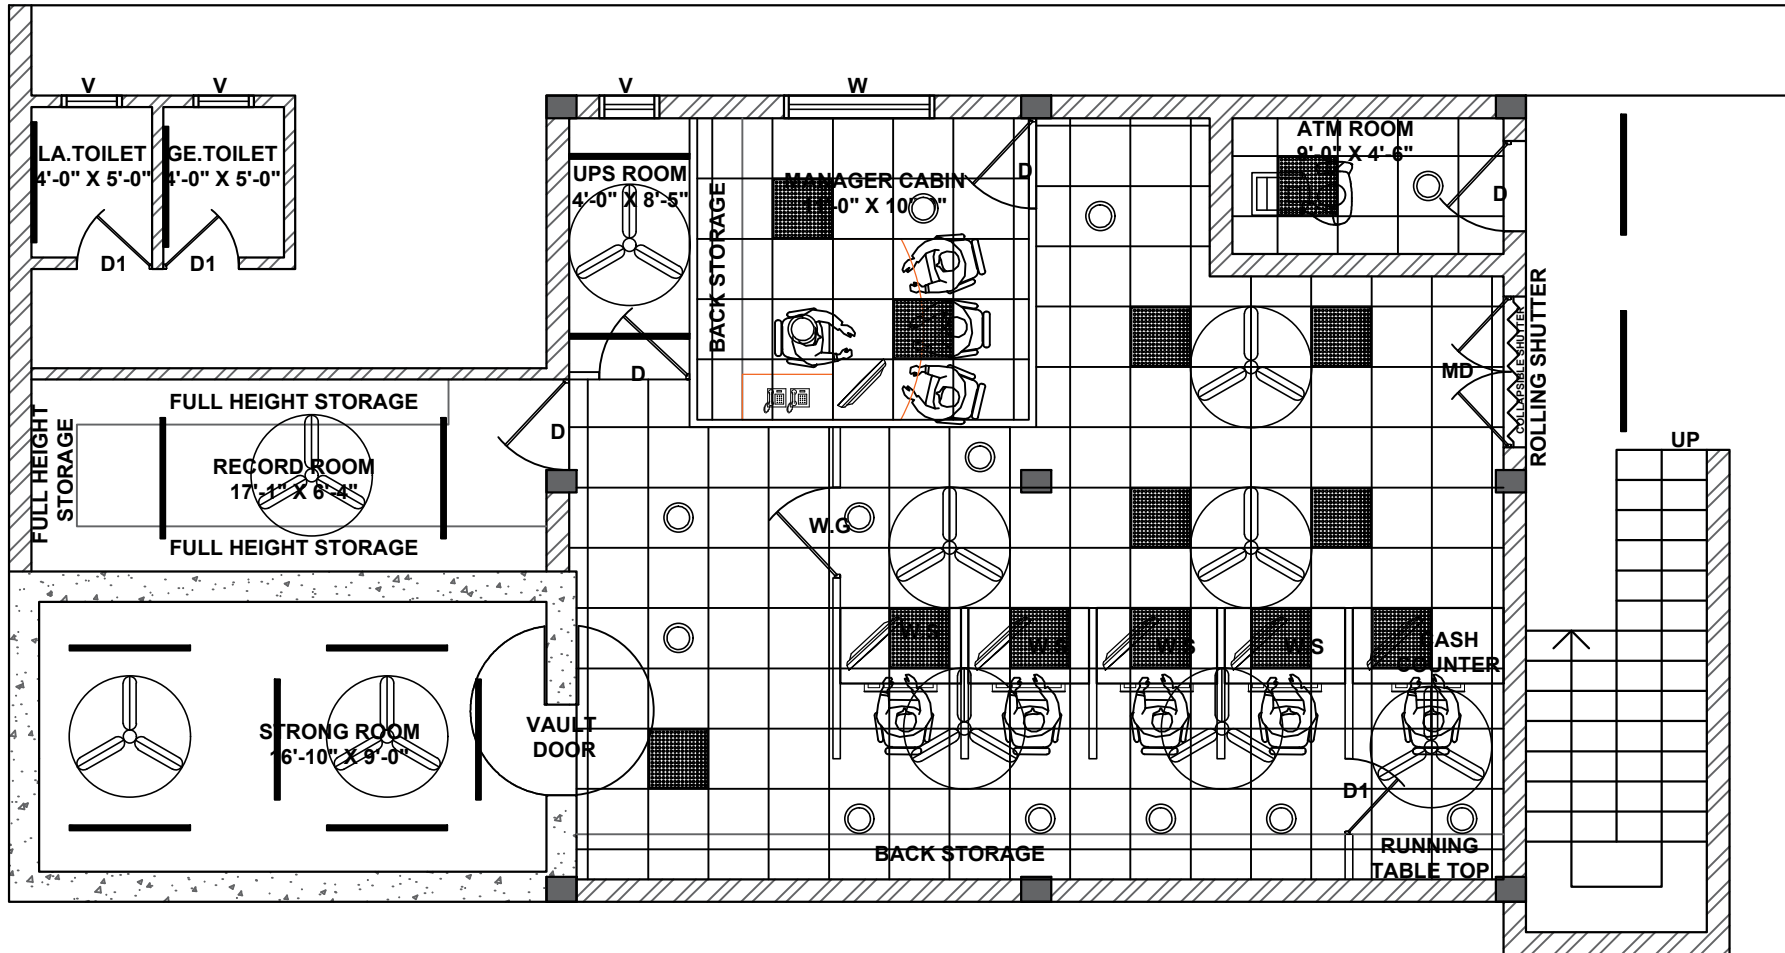

## ELECTRICAL LAYOUT

PROJECT:-

PROPOSED INTERIOR PROJECT FOR DCCB BANK,  
CHERUVU MADHARAM BRANCH AT CHERUVU MADHARAM,  
TELANGANA.

TITLE:-

ELECTRICAL LAYOUT

Sign:-



SCALE:-

N.T.S

DATE:-

14/03/2025

DRAWN:-

VISHNU VARDHAN

CHECKED:-

SHYAM RAJ



SRR Architechniques  
Architects, Planners & Engineers

Address:  
Jyoti, 2nd Floor, Galla Kalyan Apartments, Street No. 1, Vijayapuri,  
Hyderabad, Telangana, India  
E: info@srrarchitects.com P: 9849111111