


KANDUKURU BRANCH

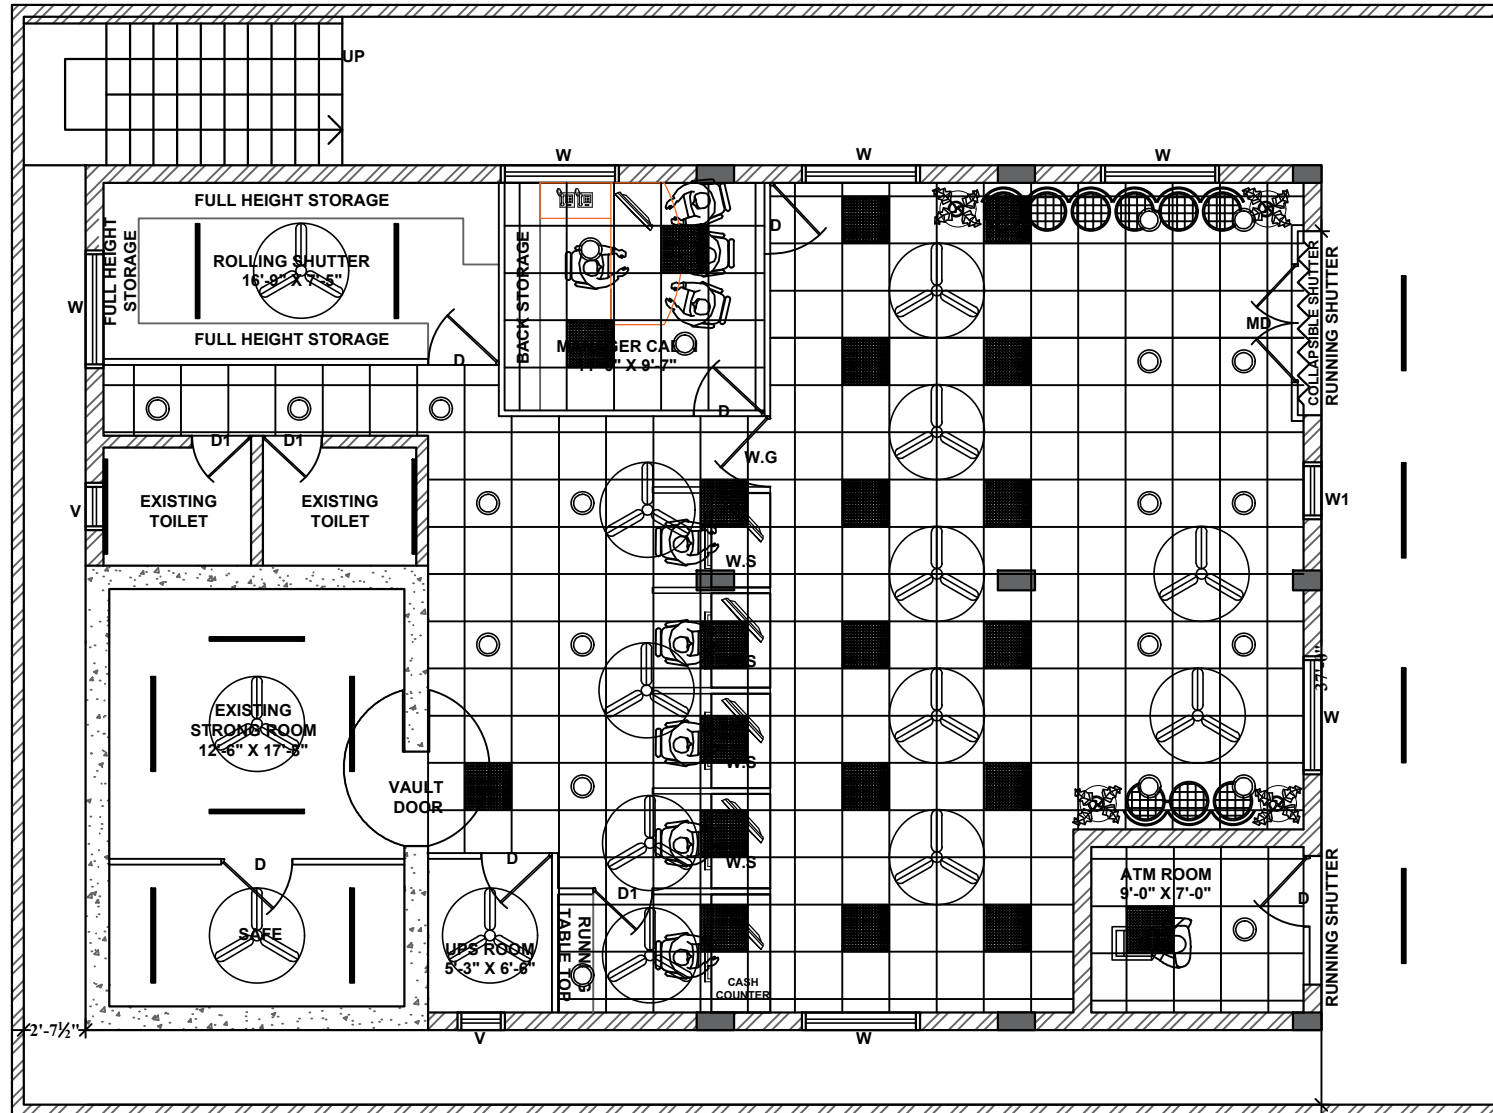

ELECTRICAL LAYOUT

PROJECT:-

PROPOSED INTERIOR PROJECT FOR DCCB BANK
KANDUKURU BRANCH AT KANDUKURU, TELANGANA.

TITLE:-

ELECTRICAL LAYOUT

Sign:-



SCALE:-

N.T.S

DATE:-

13/03/2025

DRAWN:-

VISHNU VARDHAN

CHECKED:-

SHYAM RAJ



SRR Architechniques
Architects, Planners & Engineers

Address: jalapa, c/o. G. S. K. Reddy Apartments, Street No. 1, Vijayapuri,
Hyderabad, Telangana, India
E: info@srrarchitects.com | M: 9959554444