


MANUGURU BRANCH

R O A D

ELECTRICAL LAYOUT

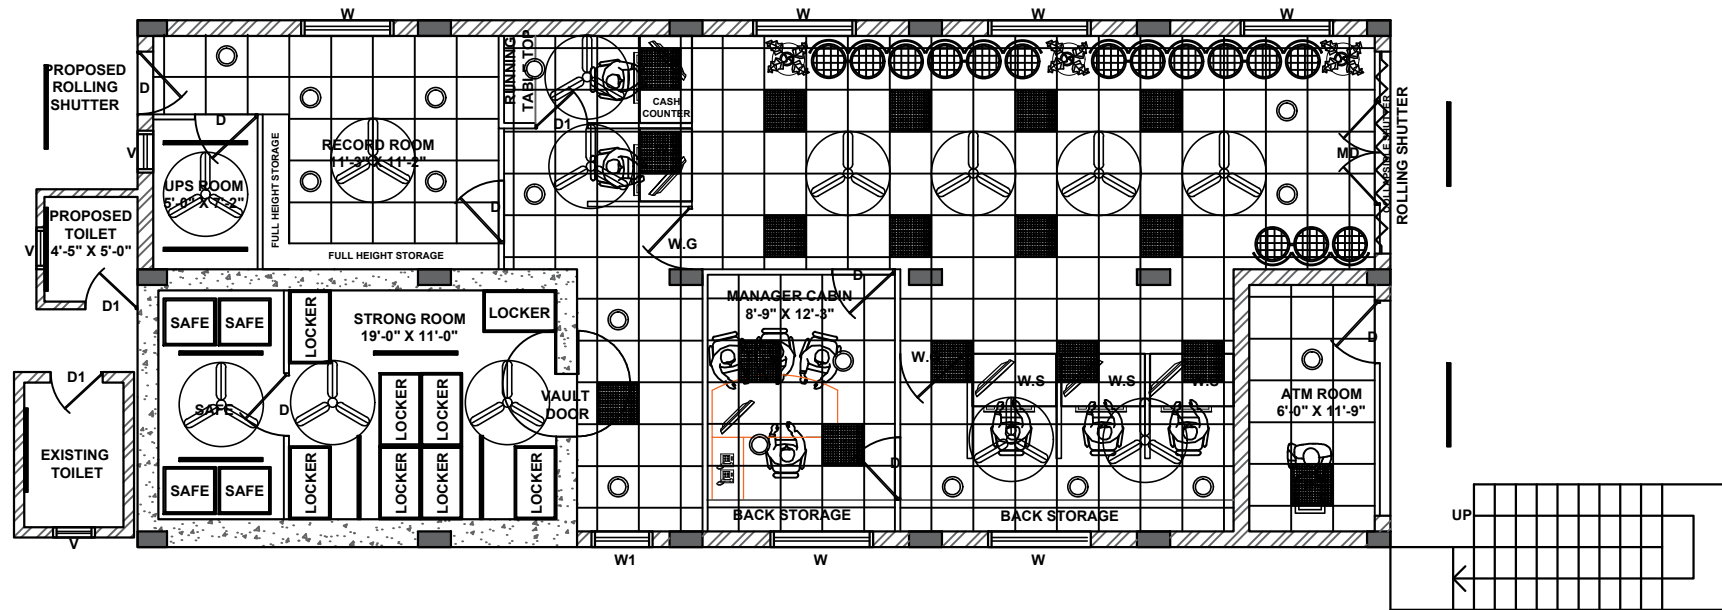

PROJECT:-

PROPOSED INTERIOR PROJECT FOR DCCB BANK
MANUGURU BRANCH AT MANUGURU, TELANGANA.

TITLE:-

ELECTRICAL LAYOUT

Sign:-



SCALE:-

N.T.S

DATE:-

12/03/2025

DRAWN:-

VISHNU VARDHAN

CHECKED:-

SHYAM RAJ



SRR Architechniques
Architects, Planners & Engineers

Address:
Jyoti, 6th Floor, Ganga Kalyan Apartments, Street No. 1, Vijayapuri,
Hyderabad, Telangana, India
E: info@srrarchitects.com P: 9849115446